


Item No.	REFRIGERATION EQUIPMENT DESCRIPTION	SET/NO
11, 21	REFRIGERATION COMPRESSOR UNIT FOR IQF FREEZER	2
12, 22	REFRIGERATION COMPRESSOR UNIT FOR COLD ROOM	1
13, 23	REFRIGERATION COMPRESSOR UNIT FOR AIR CONDITION	1
14	NH3 PUMP FOR IQF FREEZER	4
14	NH3 PUMP FOR COLD ROOM	2
9	EVAPORATIVE CONDENSER	2
31	SPIRAL FREEZER	2
61	UNIT COOLER FOR FREEZER ROOM	2
62	UNIT COOLER FOR CHILLED ROOM	2
63	UNIT COOLER FOR COLD STOCK ROOM	1
64	UNIT COOLER FOR SHIPPING ROOM	1
65	UNIT COOLER FOR WASTE ROOM	2
5	BRINE CHILLER FOR AIR CONDITIONING	1
61	AIR COOLER FOR RECEIVING ROOM	1
62	AIR COOLER FOR MIXING ROOM	1
63	AIR COOLER FOR DRY ROOM 1	1
64	AIR COOLER FOR MARINATE	1
65	AIR COOLER FOR PRE-HEATING ROOM	2
66	AIR COOLER FOR DRY ROOM 2	1
67	AIR COOLER FOR CARTONING ROOM	2
68	AIR COOLER FOR STOCK ROOM 2	1
71	AIR HANDLING UNIT FOR MARINATE AND PRE COOKING FRESH AIR	1
72	AIR HANDLING UNIT FOR PRE-FREEZING ROOM AIR CIRCULATION	1
73	AIR HANDLING UNIT FOR PACKING ROOM AIR CIRCULATION	1
74	AIR HANDLING UNIT FOR FAN FILTER UNIT FOR FRESH AIR	1
10	STARTER AND CONTROL PANEL	1
11	BRINE CIRCULATION PUMP FOR AIR CONDITIONING	2
121	HIGH PRESSURE RECEIVER	1
122	OIL PURGE DRUM	1
123	LOW PRESSURE RECEIVER FOR IQF FREEZER	2
124	LOW PRESSURE RECEIVER FOR COLD ROOM	1
125	SURGE DRUM FOR BRINE CHILLER	1

LIST NO.	ITEM	DESCRIPTION	SET/NO
11	19	PREPARING EQUIPMENT	9
12	14	LIFT UP WAGON MACHINE	2
13	15	PALETTER	2
14	16	FOLKLIFT	1
15			
16	18	BATTER MIXER	1
17	19	MARINATE MIXER	1
18	20	FLOOR SCALE	1
19	100	BATTERING MACHINE TEMPUMIXER MODULE 2 UNIT P.4	2
		HEATING EQUIPMENT	
21	30	FRYER (LINE 1-1)	1
22	31	STEAM COOKER (LINE 1-2)	1
23	32	FRYER (LINE 2-1)	1
24	33	FRYER (LINE 2-2)	1
25			
26	35	OIL MIST SEPARATOR (LINE 1-1)	1
27	36	OIL MIST SEPARATOR (LINE 2-1)	1
28	37	OIL FILTER (LINE 1-1)	1
29	38	OIL FILTER (LINE 2-1)	1
30	39	OIL FILTER (LINE 2-2)	1
31	40	OIL TANK (LINE 1-1)	1
32	41	OIL TANK (LINE 2-1)	1
33	42	OIL TANK (LINE 2-2)	1
34	43	INPUT CONVEYOR (LINE 1)	1
35	44	INPUT CONVEYOR (LINE 2)	1
36	45	CONNECTING CONVEYOR (LINE 1)	1
37	46	CONNECTING CONVEYOR (LINE 2)	1
38			
39	48	OUTLET CONVEYOR (LINE 1, 2, 3)	3
40	49	TRANSFER CONVEYOR STEAM TO FREEZER	1

LIST NO.	ITEM	DESCRIPTION	SET/NO
		PACKING EQUIPMENT	
31	50	V-CHAMBER PACKING MACHINE	3
32	51	ISHIDA WEIGHER COMPUTER SCALE	1
33	52	BUSKET CONVEYOR	1
34	53	KAWAJIMA PACKING MACHINE	1
35	54	BUSKET CONVEYOR	1
36	55	SEALING MACHINE	2
37	56	PRINTING MACHINE	2
38	57	CONVEYOR FOR PACKING	2
39	58	AUTOMATIC SKEWERING MACHINE	
		CARTONING EQUIPMENT	
41	60	CARTONING MACHINE	2
42	61	SCALE	2
43	62	PALETTER	1
44	63	FOLKLIFT	
		CHECKING EQUIPMENT	
61	70	X-RAY DETECTING MACHINE	2
62	71	SEPARATOR	2
63	72	METAL CHECKING MACHINE	2
64	73	SEPARATOR	2
65	74	WEIGHT CHECK MACHINE	2
66	75	SEPARATOR	4
67	76	INLET CONVEYOR	2
68	77	OUTLET CONVEYOR	1
78		RIBBON MIXER MODEL TRM-500	1
79		OIL EXTRACT MACHINE	
80		FLOUR AND BREADING FEEDER (SCREW FEEDER)	
81		MAKE MIXER POWDER (BUTTER MIXER)	1
82			
83		ANRITSU KD 802AV METAL DETECTOR	1
84		COUNTER MACHINE	1
85		VIBRATING SIFTER SIFTOMIC SA 800	1
86		CABINET ICE STORAGE TANK	1
87		FLAKE ICE MACHINE PHASE 4 ND1	1
88		FLAKE ICE MACHINE PHASE 4 ND2	1
89		EVAPORATIVE CONDENSOR	1
90		OBERLIN OIL PRESSURE FILTER MODEL 07	1
91		X-RAY INSPECTION SYSTEM IX-G2-4027-E	1
92		VACUUM TRUMBLER	1
93		ANRITSU MODEL KDS4505ABW METAL DETECTOR	1
94		ANRITSU MODEL KV466CV REJECTOR DROPOUT TYPE	1
95		THERMAL PRINTER OF GP MACHINE	1
96		PROJECT ROBOT CARTONING P.4 PACKING ROOM	1
97		VACUUM TUMBLER (SCANNING+COLUMN/LOADER 300S)	2
98		CD-PILOT INKJET PRINTING SYSTEM	1
99		SUNMAX FLOURING LINE UNCOOK P.4 SM-PDM600-1500	1

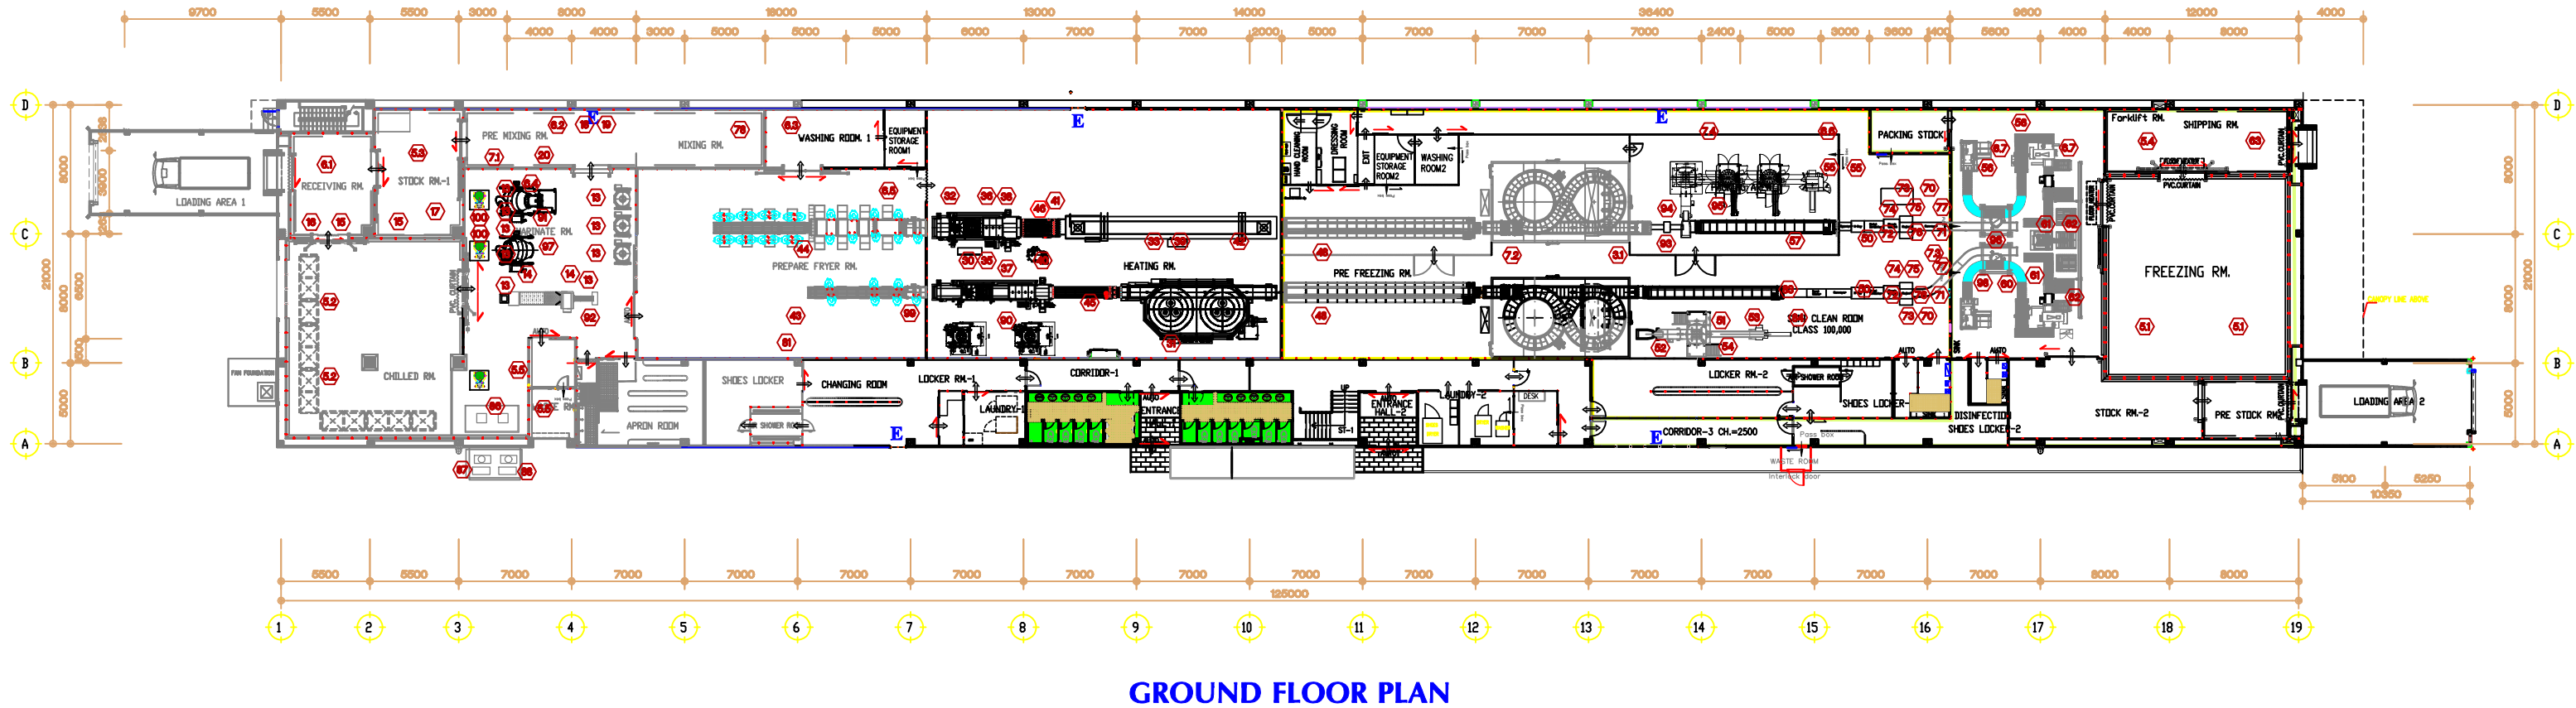

MESSRS. THAI NIPPON FOODS CO., LTD.				
EST 29 (Plant B)				
DRAWING OF. FLOOR PLAN WITH MACHINE LAYOUT				
		PROJECT No.		REV.
		DRAWING No. GOVERNMENT 2021		
	DESIGNED	DRAWN	CHECKED	APPROVED
NAME		LPRADITH		
DATE		MAY -2022		